


This drawing and the information contained herein, is the sole property of Steelgal NZ Limited and may not be used without consent from Steelgal NZ Limited.

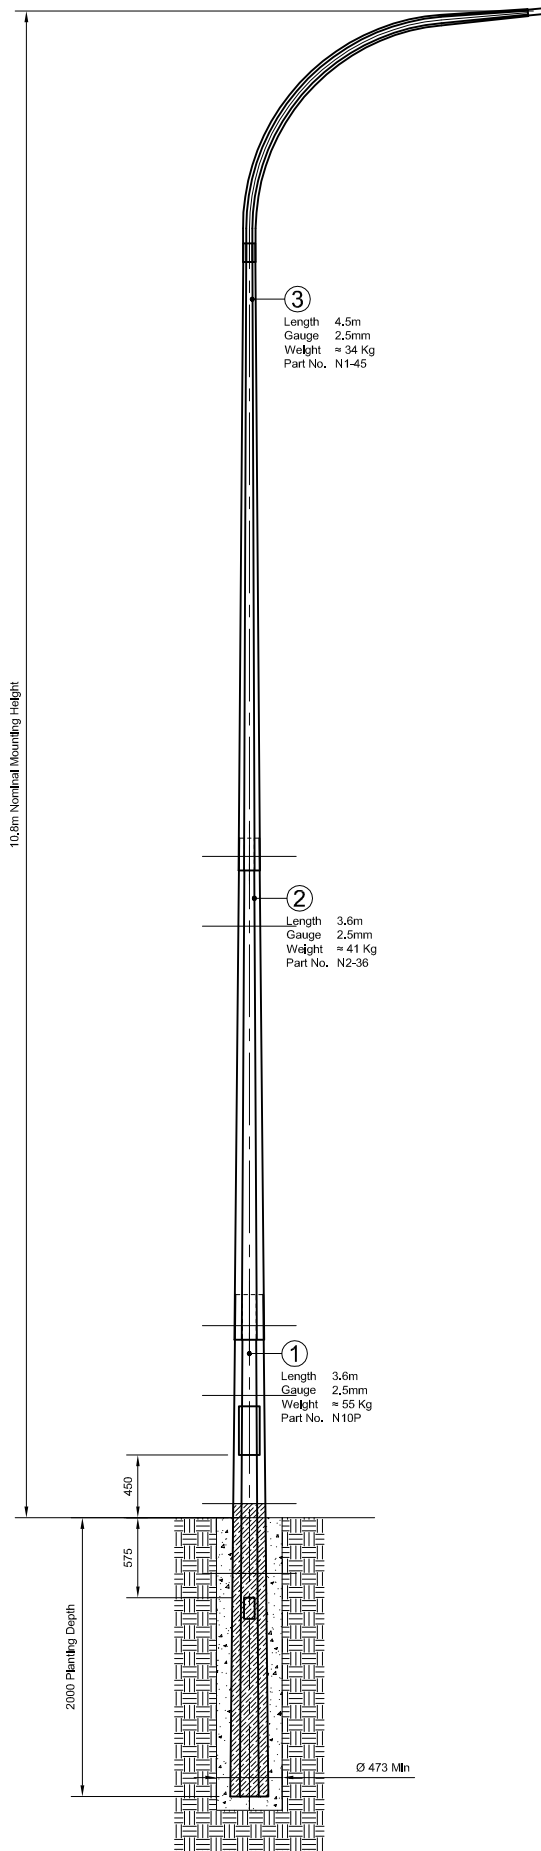

OT-SLS-108-P-1

**Standards**

Pole Design AS 4676 / AS 1170.2 Sect'n4 / NZS 4203  
 Material EN 12767 Class 0 / BS 4360 / BS EN 10025  
 Welding (Electric Arc Welding) AS 1554  
 Galvanising AS / NZS 4680

**Testing Procedures**

Dimensional Verification  
 Galvanising Thickness  
 Material Thickness

**Quality Control Procedures**

The Supplier/Manufacturer and Galvanizer of the column shall be ISO 9001 : 2000 accredited

**Finishing Types**

Oven Baked Powder Coated  
 High Performance Polyester UV Resistance. (formulated for galvanized surface)  
 Hot Dip Galvanized  
 2 Part Epoxy Coat (10 Years)

**Foundation Design**


Foundation Design by others  
 PS1 Designs by Request

**Other Information**

Gear Door - 300mm x 150mm

Cable Entry - 150mm x 75mm

Protective Epoxy Paint (Sigmashield 880) to NZTA and ATCoP Standards. From 100mm-200mm above ground level to section bottom.

Rev	Details	By	Chd	Date	Drawn: DDC	Title:	 Steelgal NZ Limited 8 Trugood Drive East Tamaki Auckland P: 0800 736600 F: (+649) 2724665 E: sales@steelgal.co.nz W: www.steelgal.co.nz
					Date: 23.05.2018	10.8m Octagonal Streetlight Pole with Planted Base	
					Scale: NTS		
					Checked:		
					Approved:	OT-SLS-108-P-1	
					Date:	Customer:	